


42 PROXECTORES
24 CANAIS

1

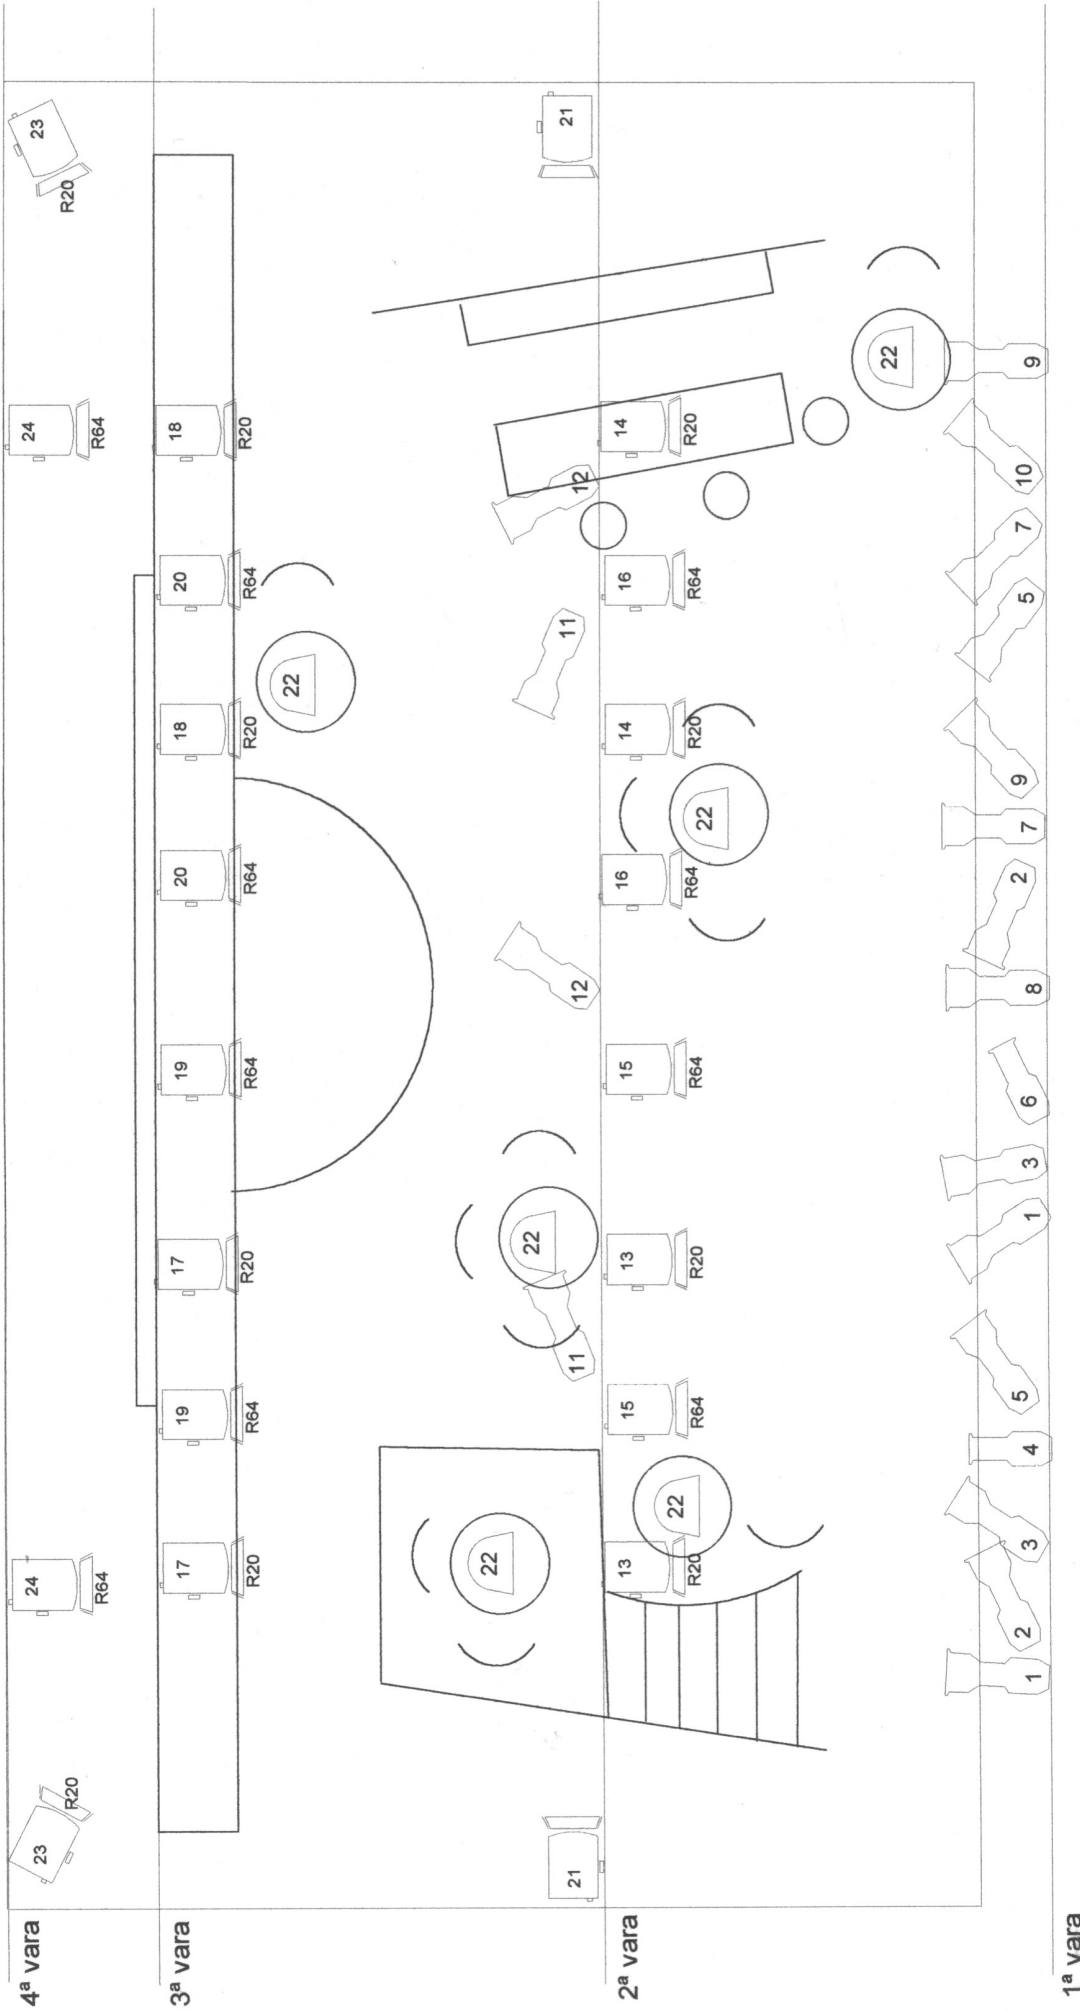

TEATRO DO NOROESTE	
IMPERIAL: CAFÉ CANTANTE. VIGO 1936	
Lighting Plan	
Dir: Eduardo Alonso	Folha:
Dsgnr: Eduardo Alonso	Escala: 1 : 50
DR Por:	Data: 06/10/06

FILTROS
ROSCO 20 AMBAR
ROSCO 64 AZUL
18 RECORTES 1.000 W 2 RECORTES 1.000 W 22 PC 1.000 W 6 LÂMPADAS 40 W
ÂNGULO MEDIO ÂNGULO PEQUENO