


39 PROXECTORES

24 CANAIS

CICLORAMA

3ª vara

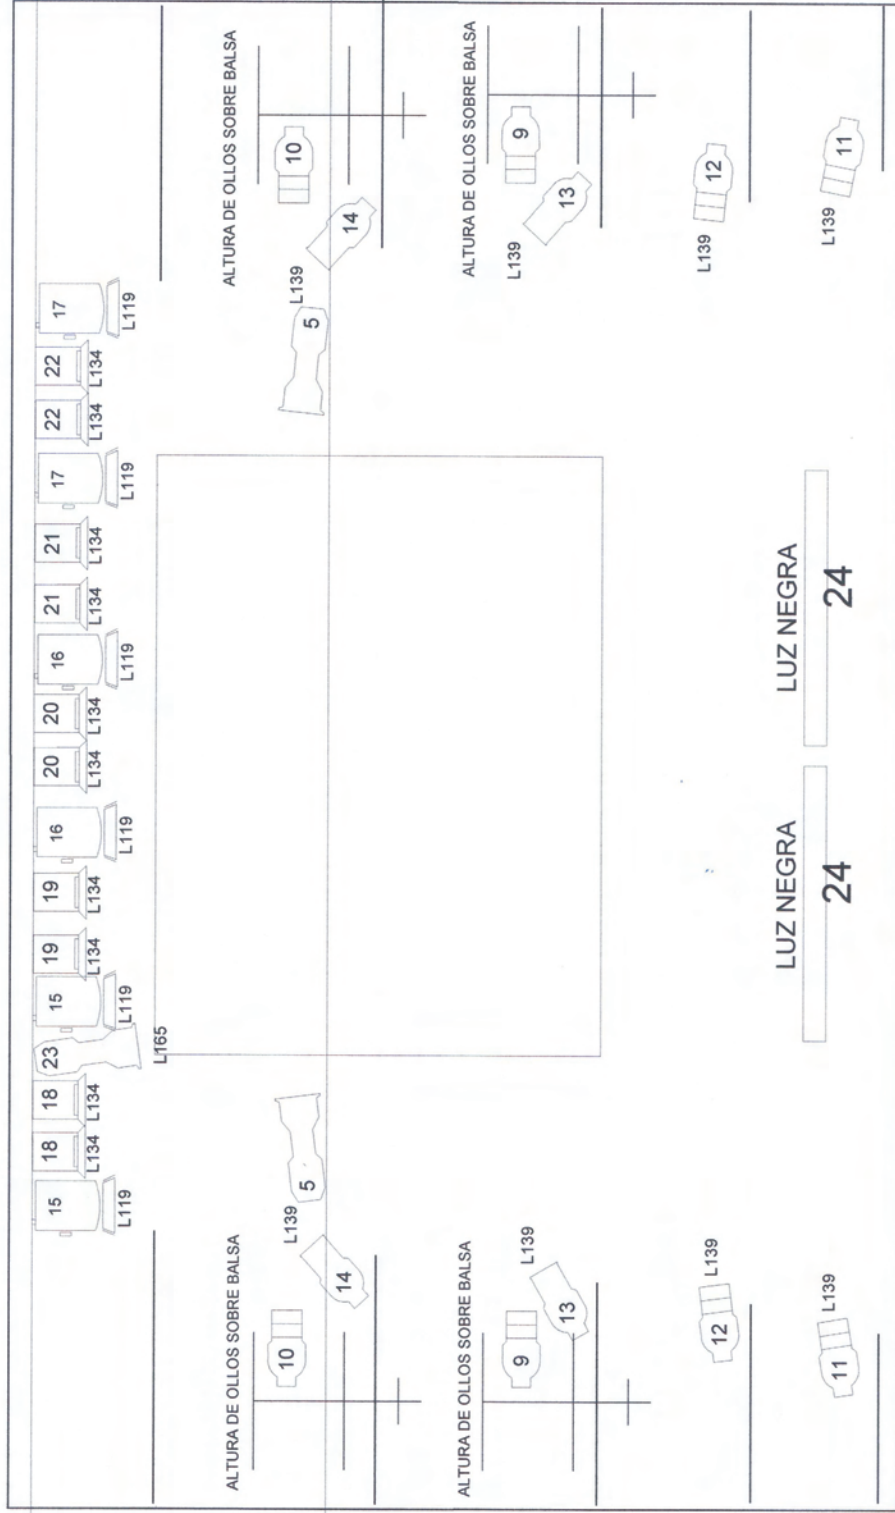

2ª vara

1ª vara



3 RECORTES
1.000 W, 15° - 28°

6 RECORTES
1.000 W, 22° - 40°

8 RECORTES
650 W, 22° - 35°

6 P.P.C
1.000 W.

10 P.C.
650 W.



GOBOS

79225 STARS 11

77752 STARS 4

FILTROS

LEE ROSCO

165 64 AZUL CLARO

119 85 AZUL ESCURO

139 90 VERDE

134 20 AMBAR

TEATRO DO NOROESTE

PIRATAS

Lighting Plan

Folha:

Escala: 1 : 50

Data: 08/10/2011

Dir: Eduardo Alonso

Dsgnr: Eduardo Alonso

DR Por: