


36 PROXECTORES  
24 CANAIS

1

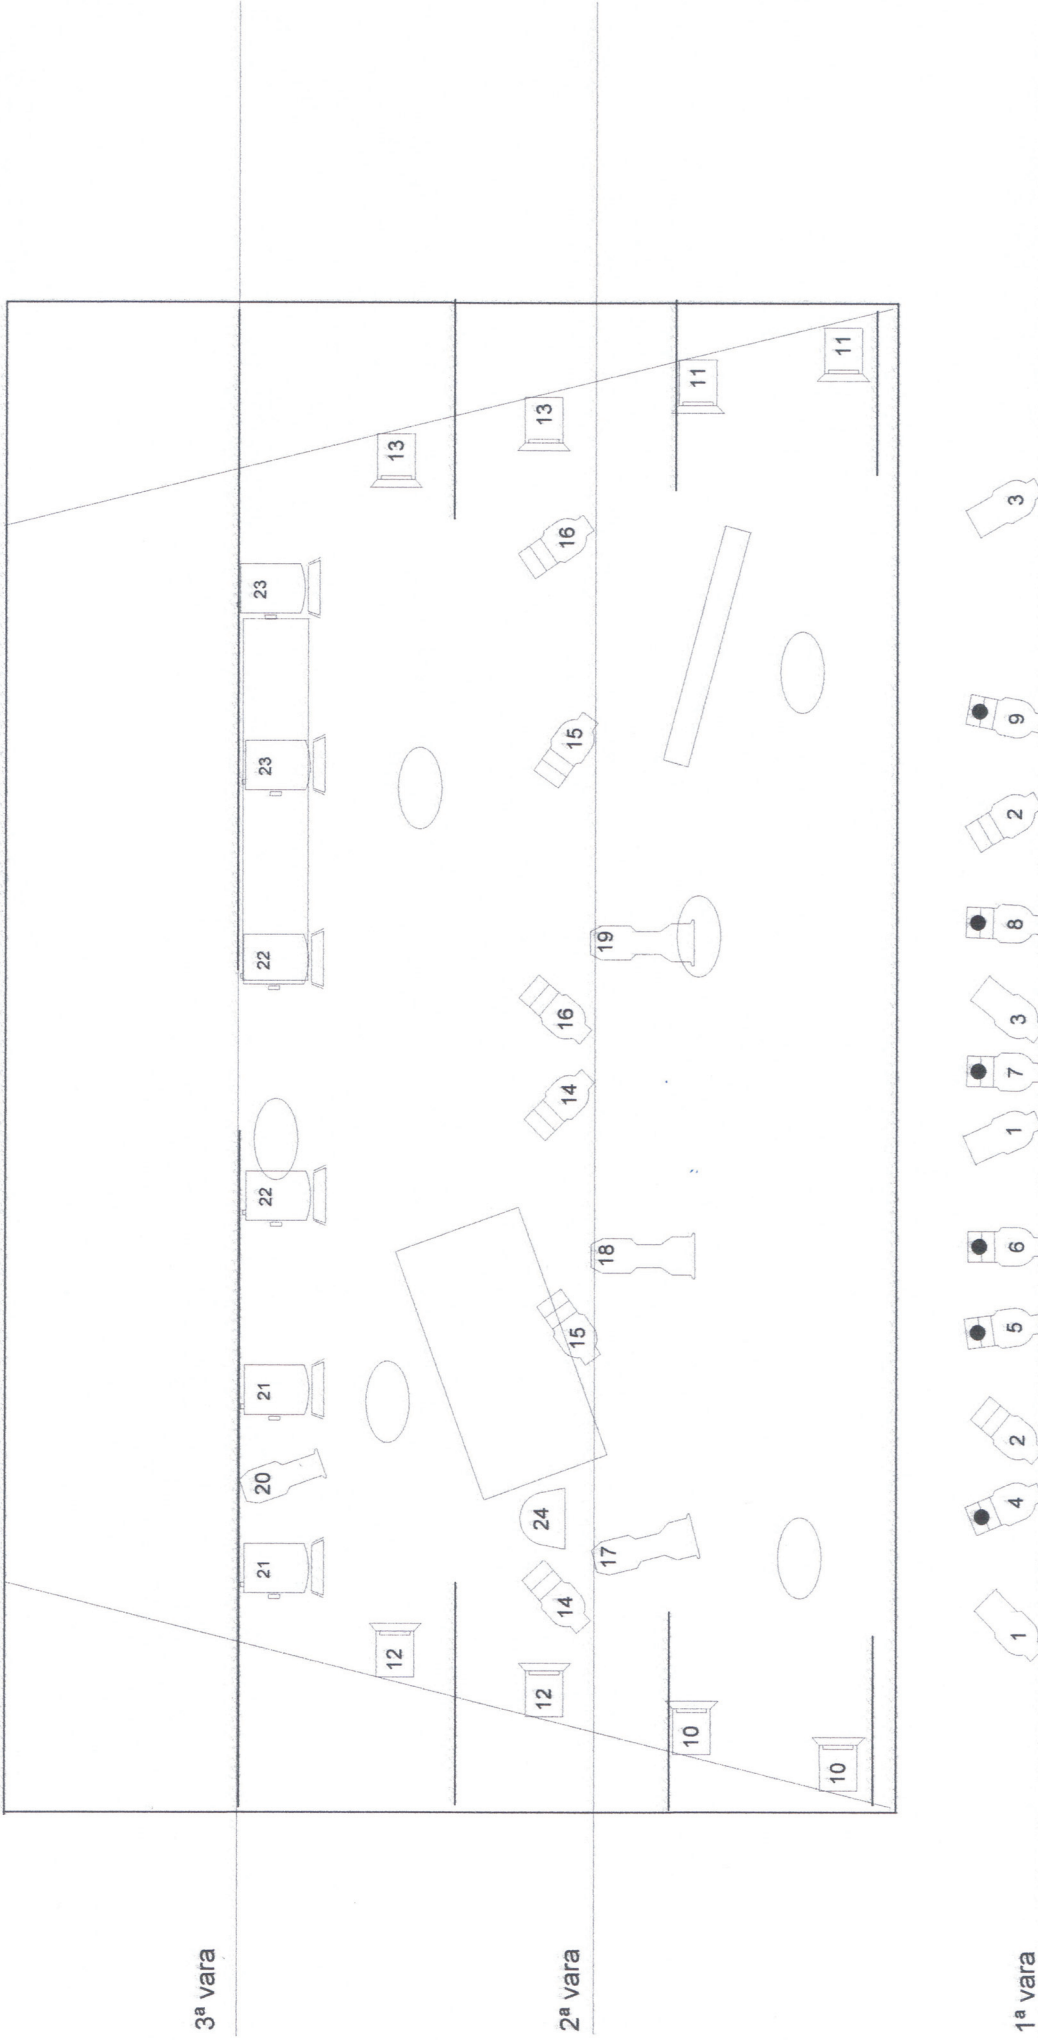

	3 RECORTES 1.000 W. 15° - 28°		6 RECORTES 650 W. 16° - 28°		8 RECORTES 650 W. 22° - 35°		4 RECORTES 650 W. 37° - 48°		6 P.P.C. 1.000 W.		8 P.C. 650 W.
--	----------------------------------	--	--------------------------------	--	--------------------------------	--	--------------------------------	--	----------------------	--	------------------

**TEATRO DO NOROESTE**  
**ÚLTIMO COWBOY**  
Lighting Plan

Dir: Eduardo Alonso Folha:  
Dsgnr: Eduardo Alonso Escala: 1 : 50  
DR Por: Data: 31/08/2011