
 
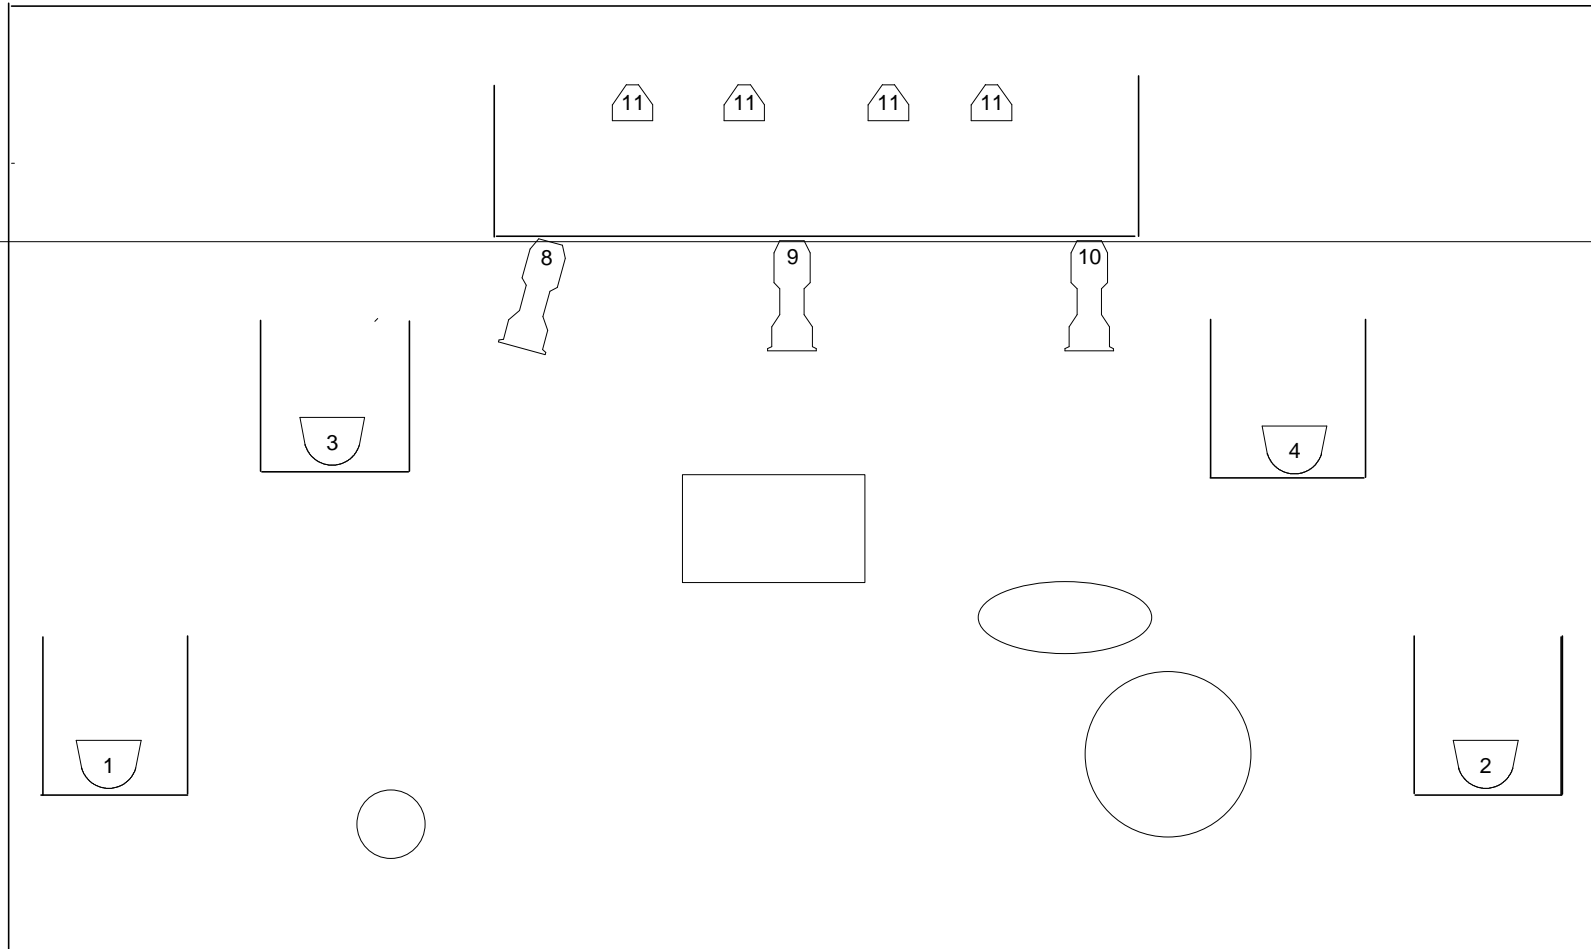



2ª vara



1ª vara

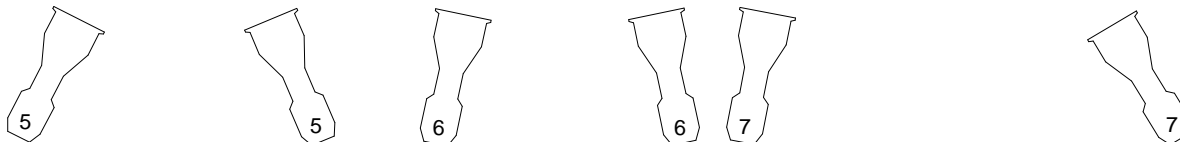

 6 RECORTES
1.000 W. 15° - 28°



3 RECORTES
1.000 W. 22° - 40°



4 PARES LED



4 LÁMPADAS LED

TEATRO DO NOROESTE

A MAMMA

Lighting Plan

Dir: Eduardo Alonso

Folha:

Dsgnr: Eduardo Alonso

Escala: 1 : 50

DR Por:

Data: 05/03/2014