 
 


5ª VARA

24 CANAIS

 


4ª VARA



3ª VARA

2ª VARA



23 RECORTES  
750 W, 25° - 50°

6 RECORTES  
750 W, 16° - 28°




 
1ª VARA

6 - 16

4 - 18

5 - 19

TUL

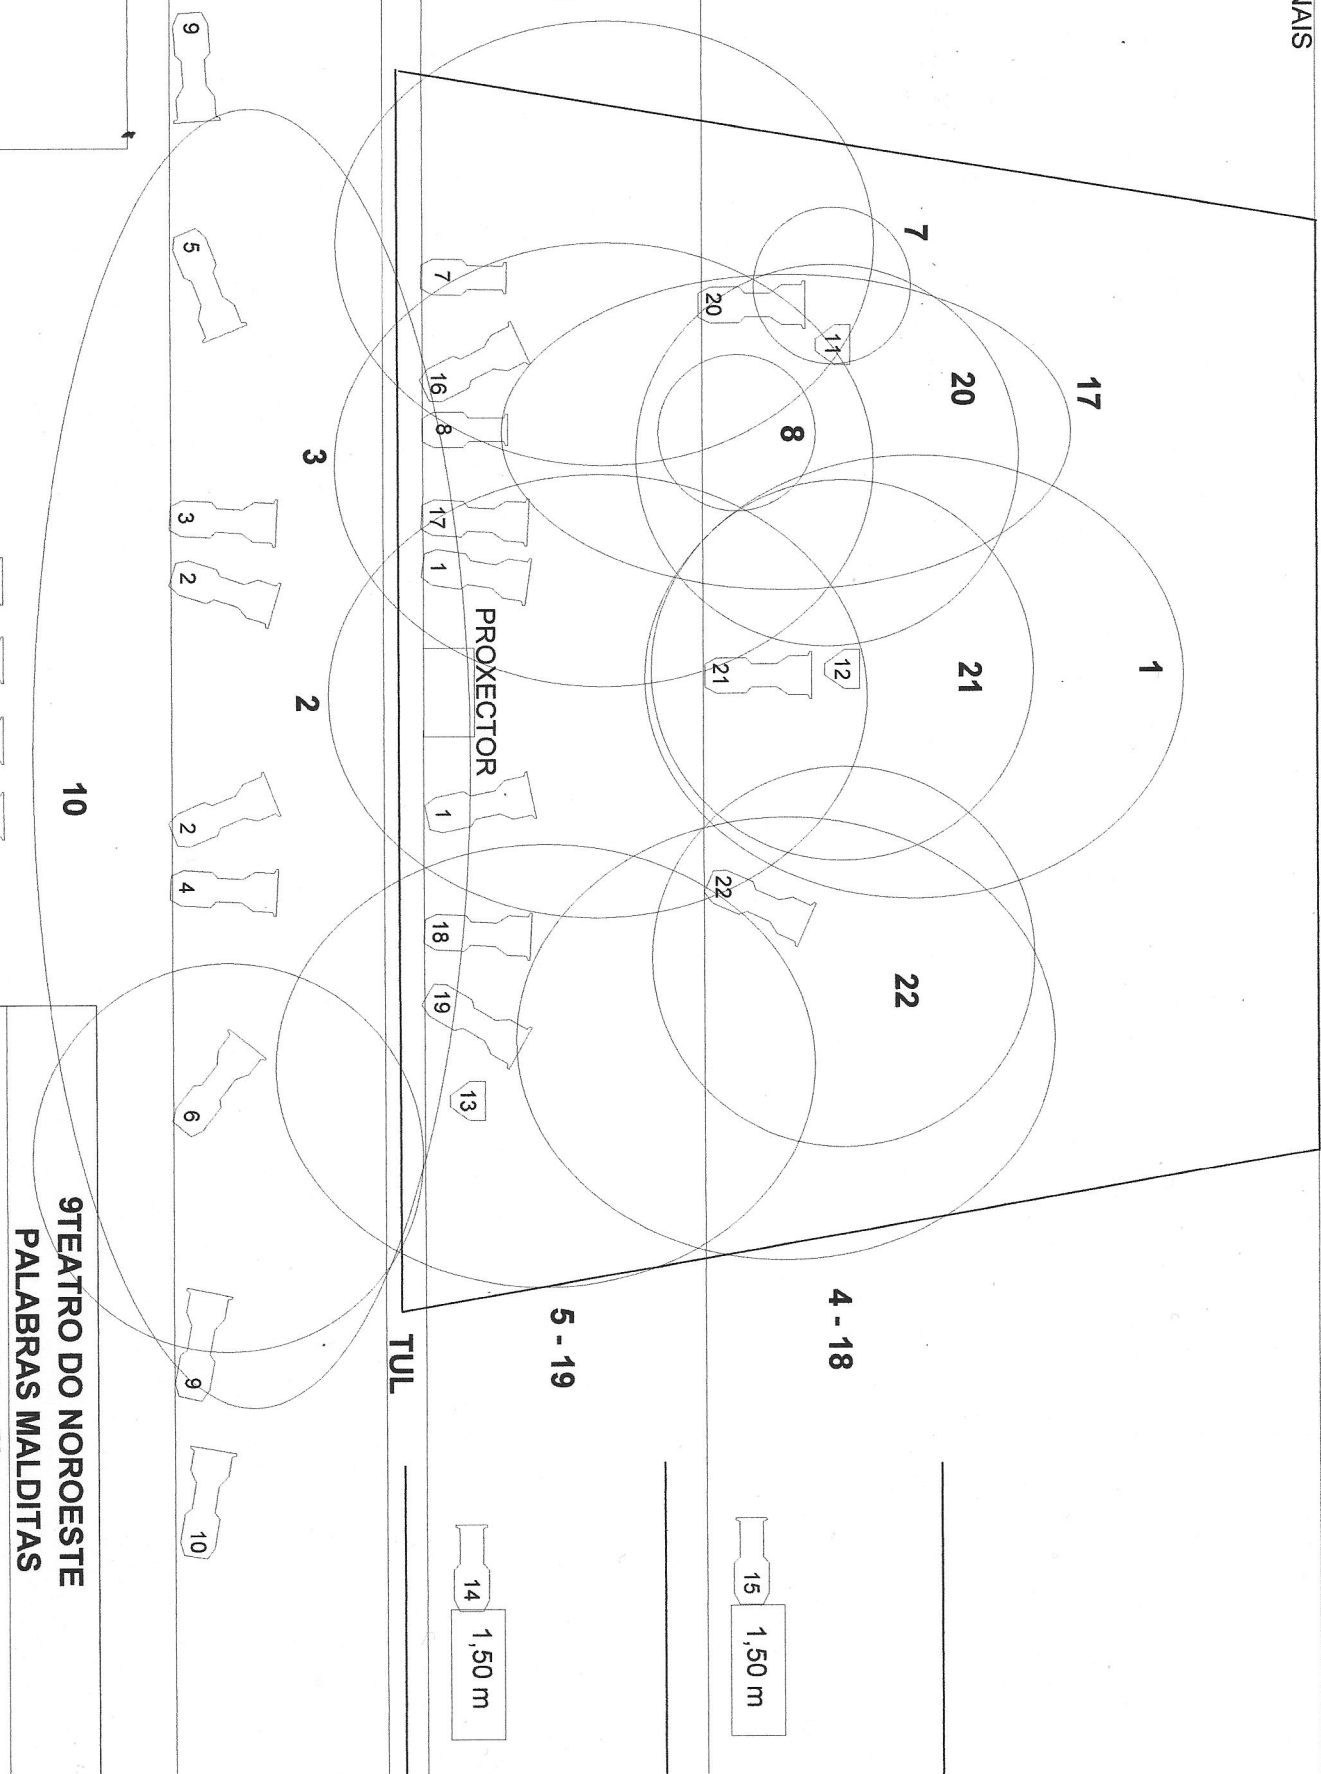

**9TEATRO DO NOROESTE  
PALABRAS MALDITAS**

Lighting Plan

Dir: Eduardo Alonso	Folha:
Dsgnr: Eduardo Alonso	Escala: 1 : 50
DR Por:	Data: 17/01/2016