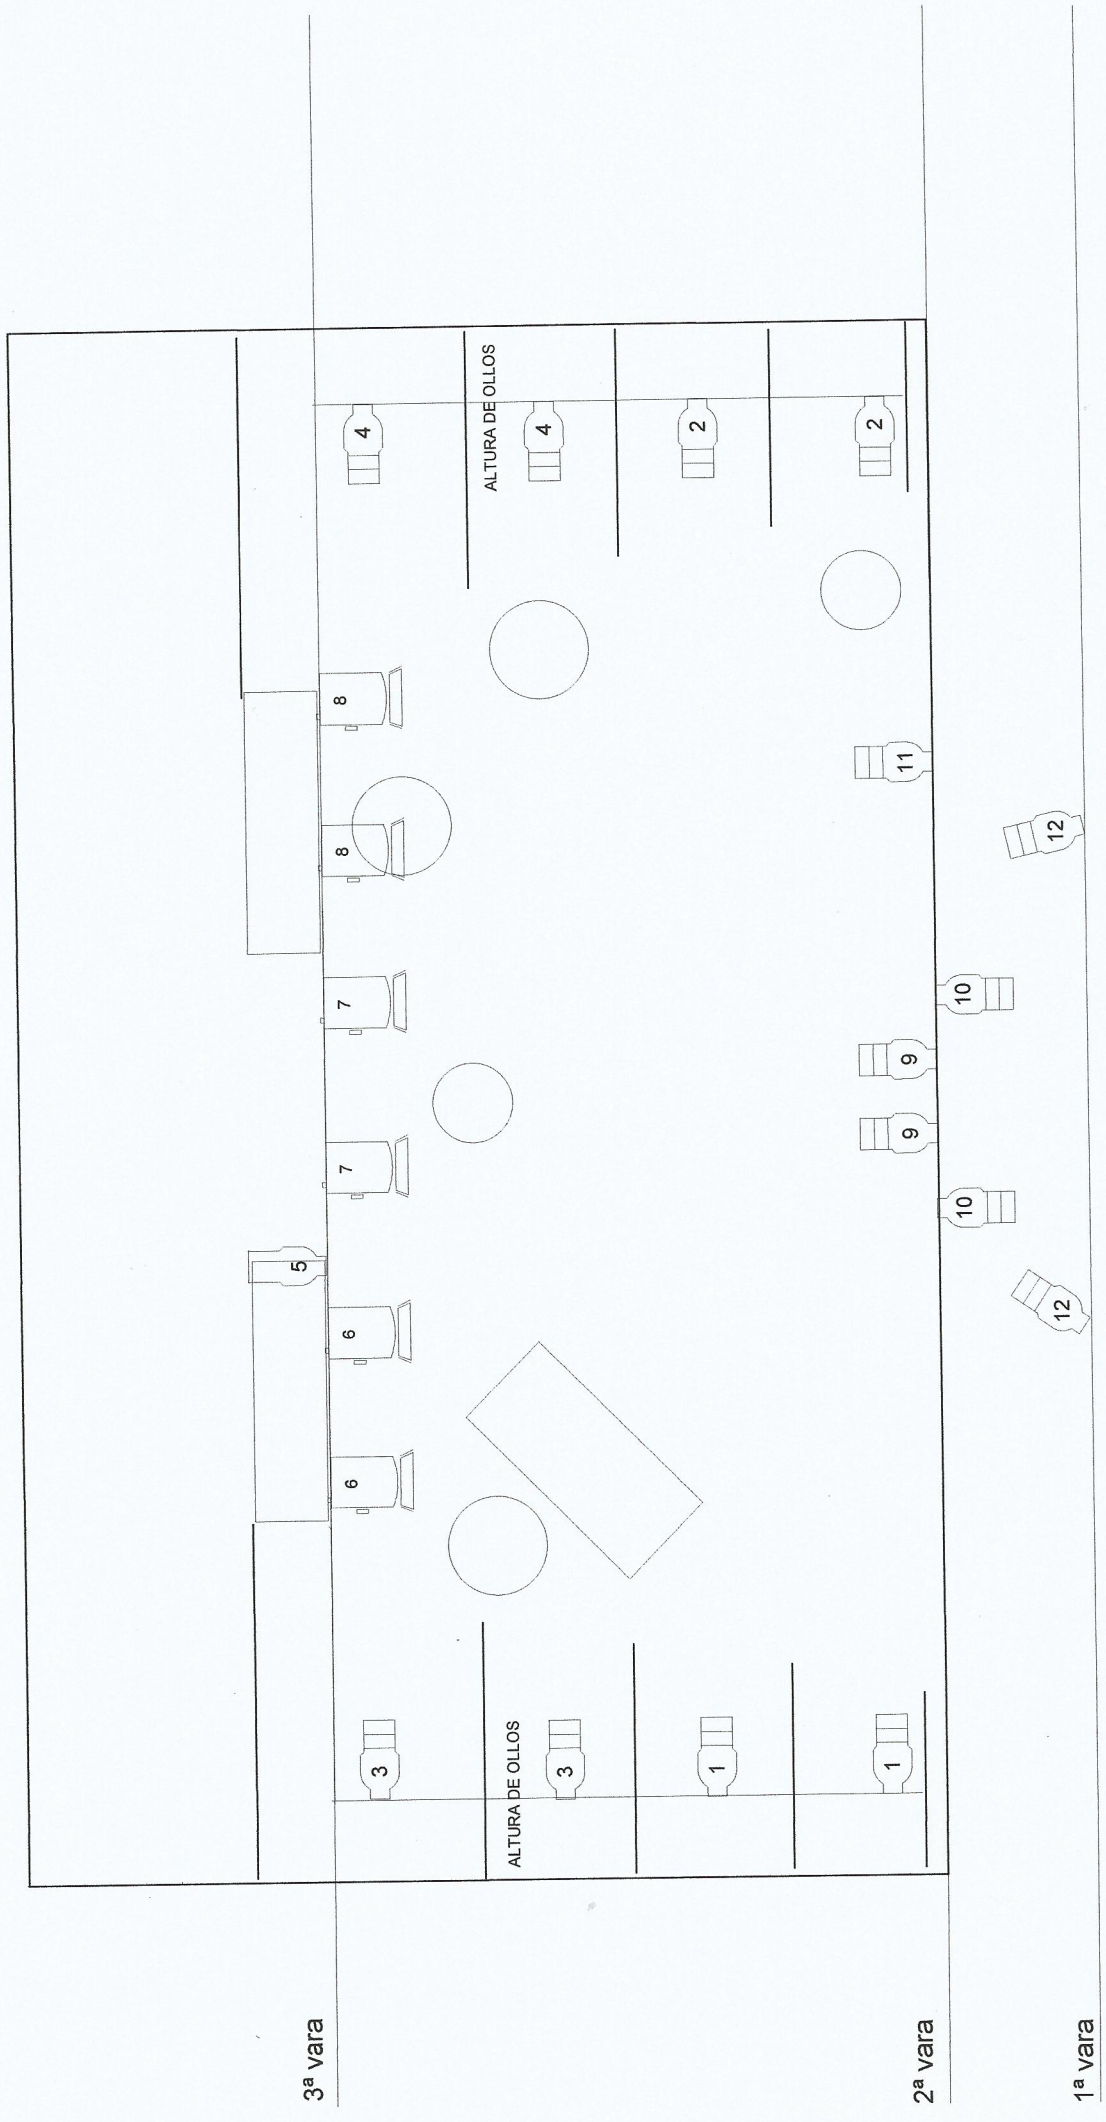
 

 


22 PROXECTORES
12 CANAIS

FONDO NEGRO

1



	1 RECORTES 1.000 W. 15° - 28°		15 RECORTES 1.000 W. 22° - 40°		6 P.P.C 1.000 W.
---	----------------------------------	---	-----------------------------------	---	---------------------

TEATRO DO NOROESTE	
LINDA AND FREDDY, ILUSIONISTAS	
Lighting Plan	
Dir: Eduardo Alonso	Folha:
Dsgnr: Eduardo Alonso	Escala: 1 : 50
DR Por:	Data: 04/01/2013